


Project No.: 2022.01
 Drawn By: BP
 Approved By: WAYNE L. COCO
 Preliminary Date: 04/20/2022
 Release Date: _____
 File: _____


WAYNE LAWRENCE COCO, AIA, ARCHITECT, L.L.C.
 SIMMESPORT OFFICE
 500 W. MAIN ST.
 P.O. BOX 71369
 SIMMESPORT, LA 71369
 (318) 941-2392 / FAX (318) 941-2821
 a professional architectural company

**JACKSON PARISH LIBRARY
 NEW INTERACTIVE PLAYGROUND**

Sheet Number:
A1.1R
 of 4

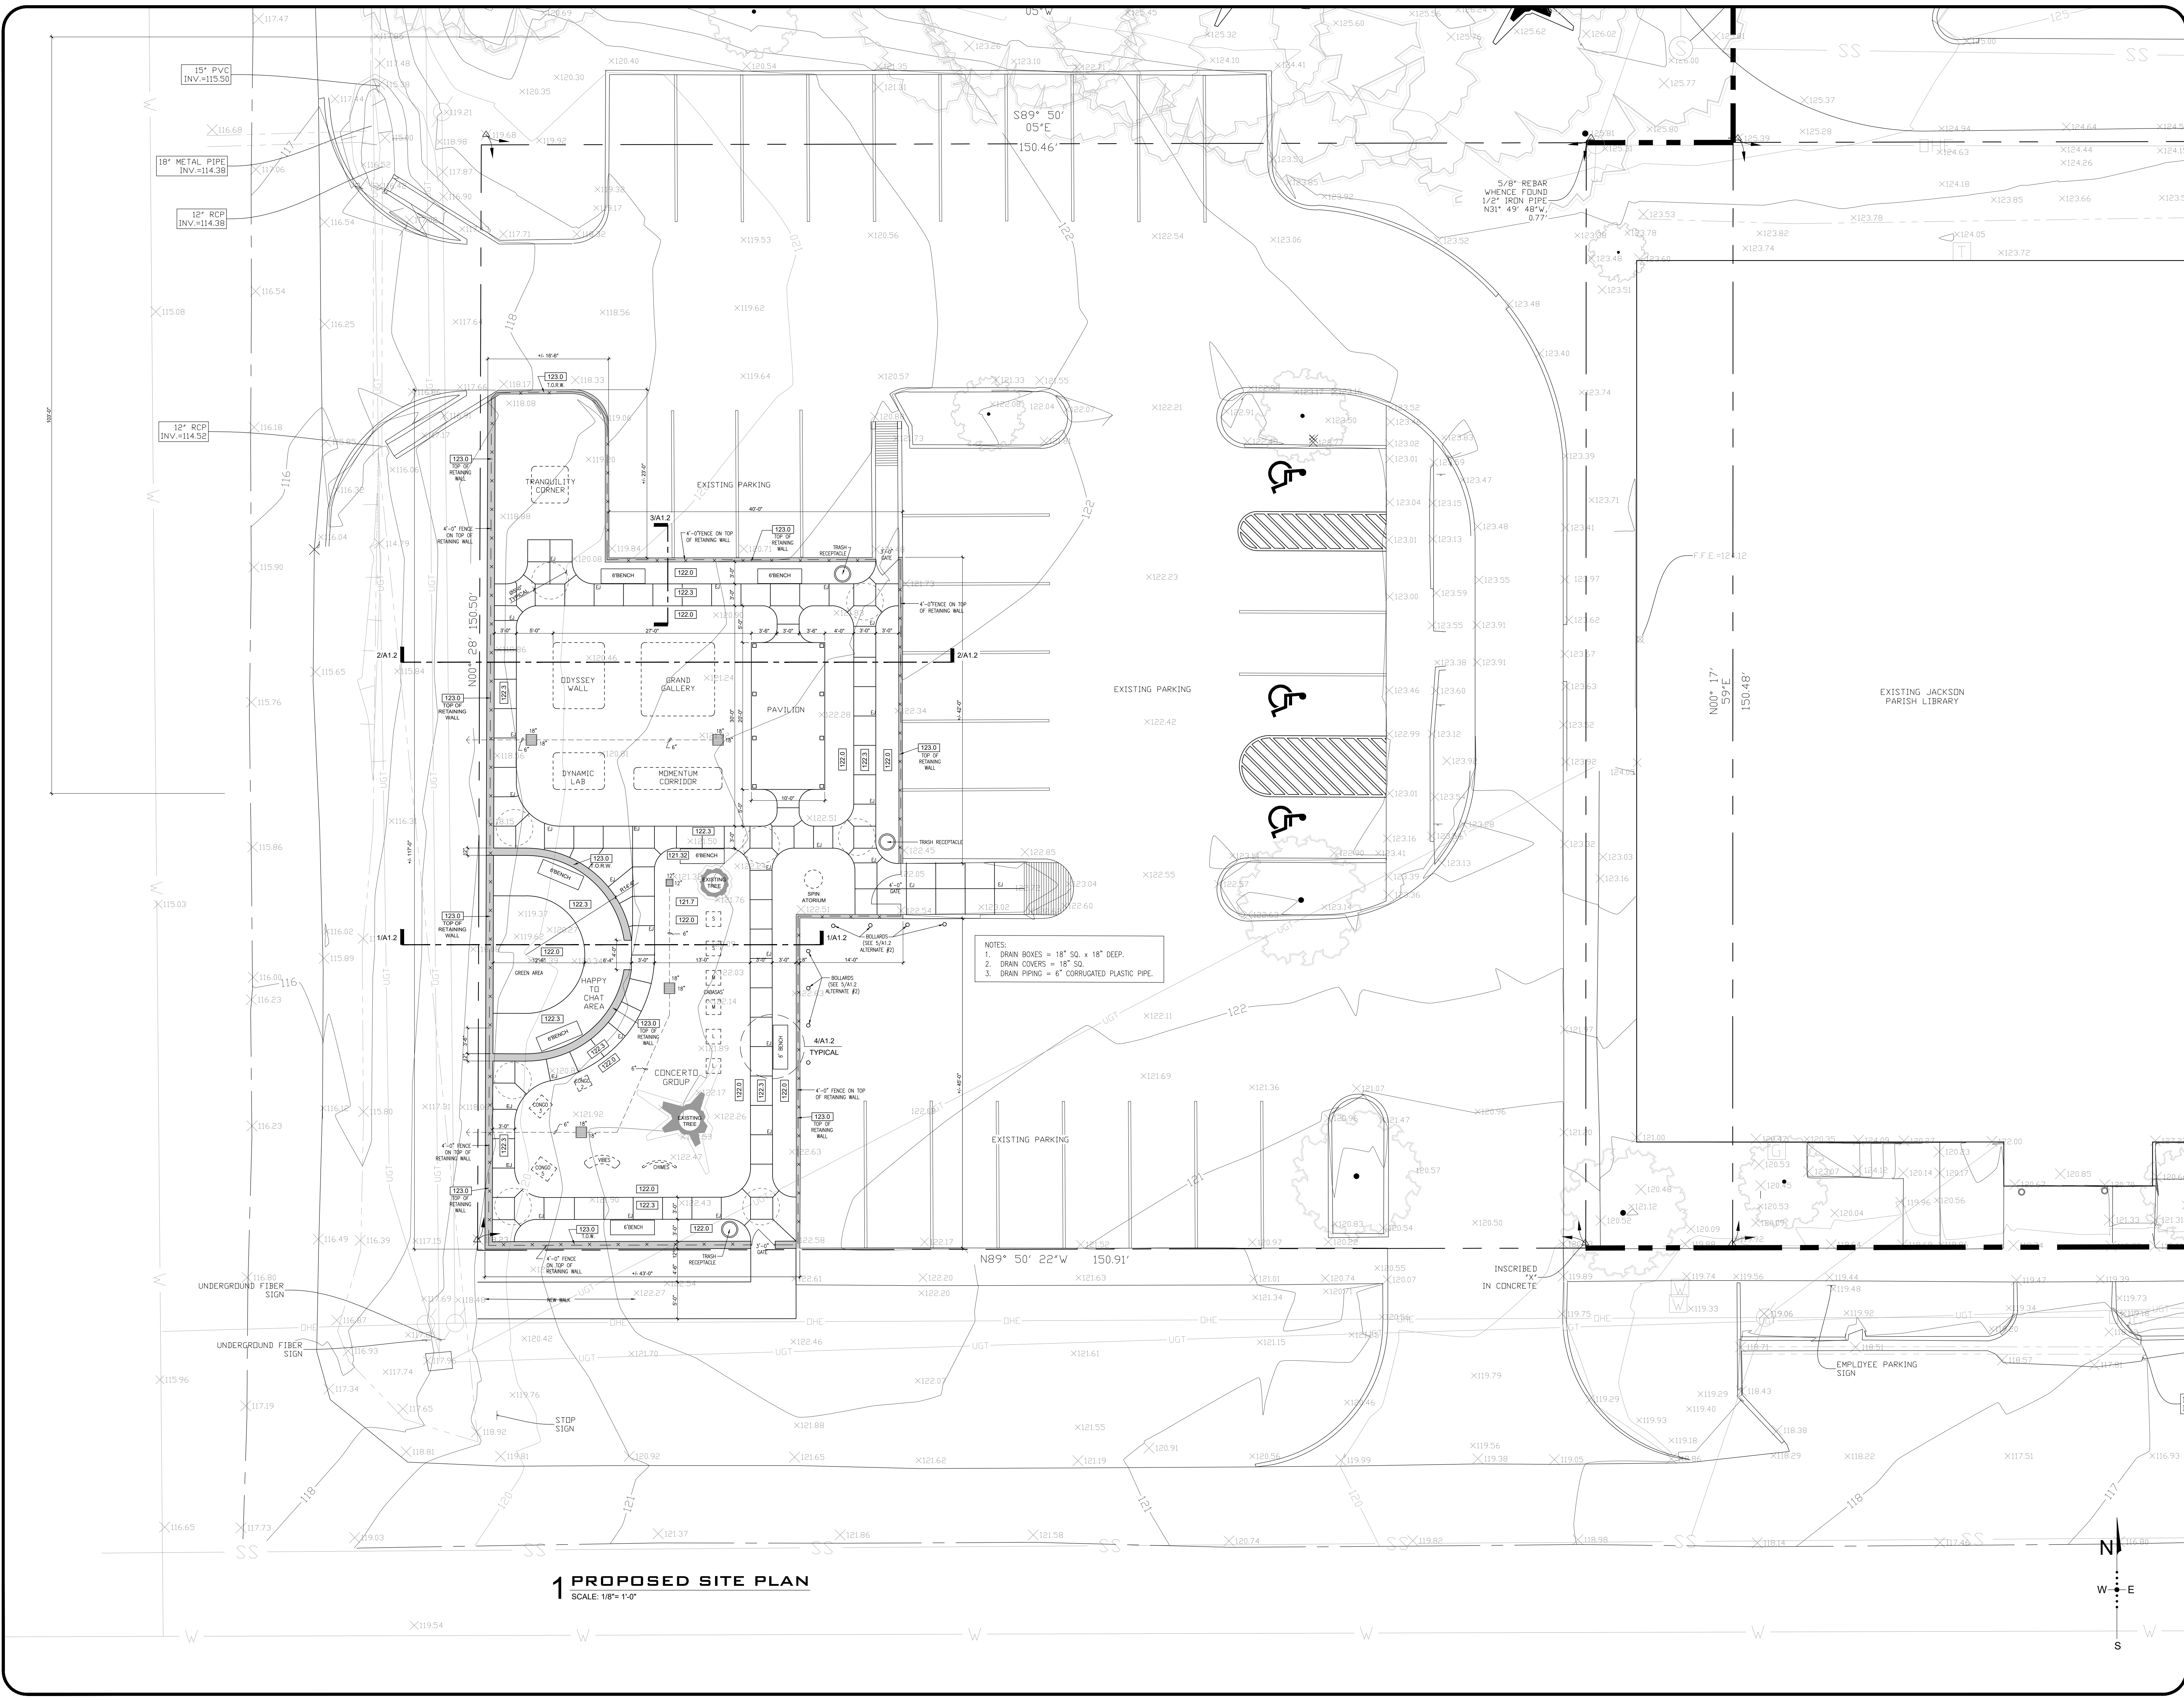

1 PROPOSED SITE PLAN
 SCALE: 1/8" = 1'-0"

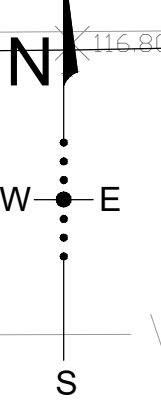

- NOTES:
 1. DRAIN BOXES = 18" SQ. x 18" DEEP.
 2. DRAIN COVERS = 18" SQ.
 3. DRAIN PIPING = 6" CORRUGATED PLASTIC PIPE.